


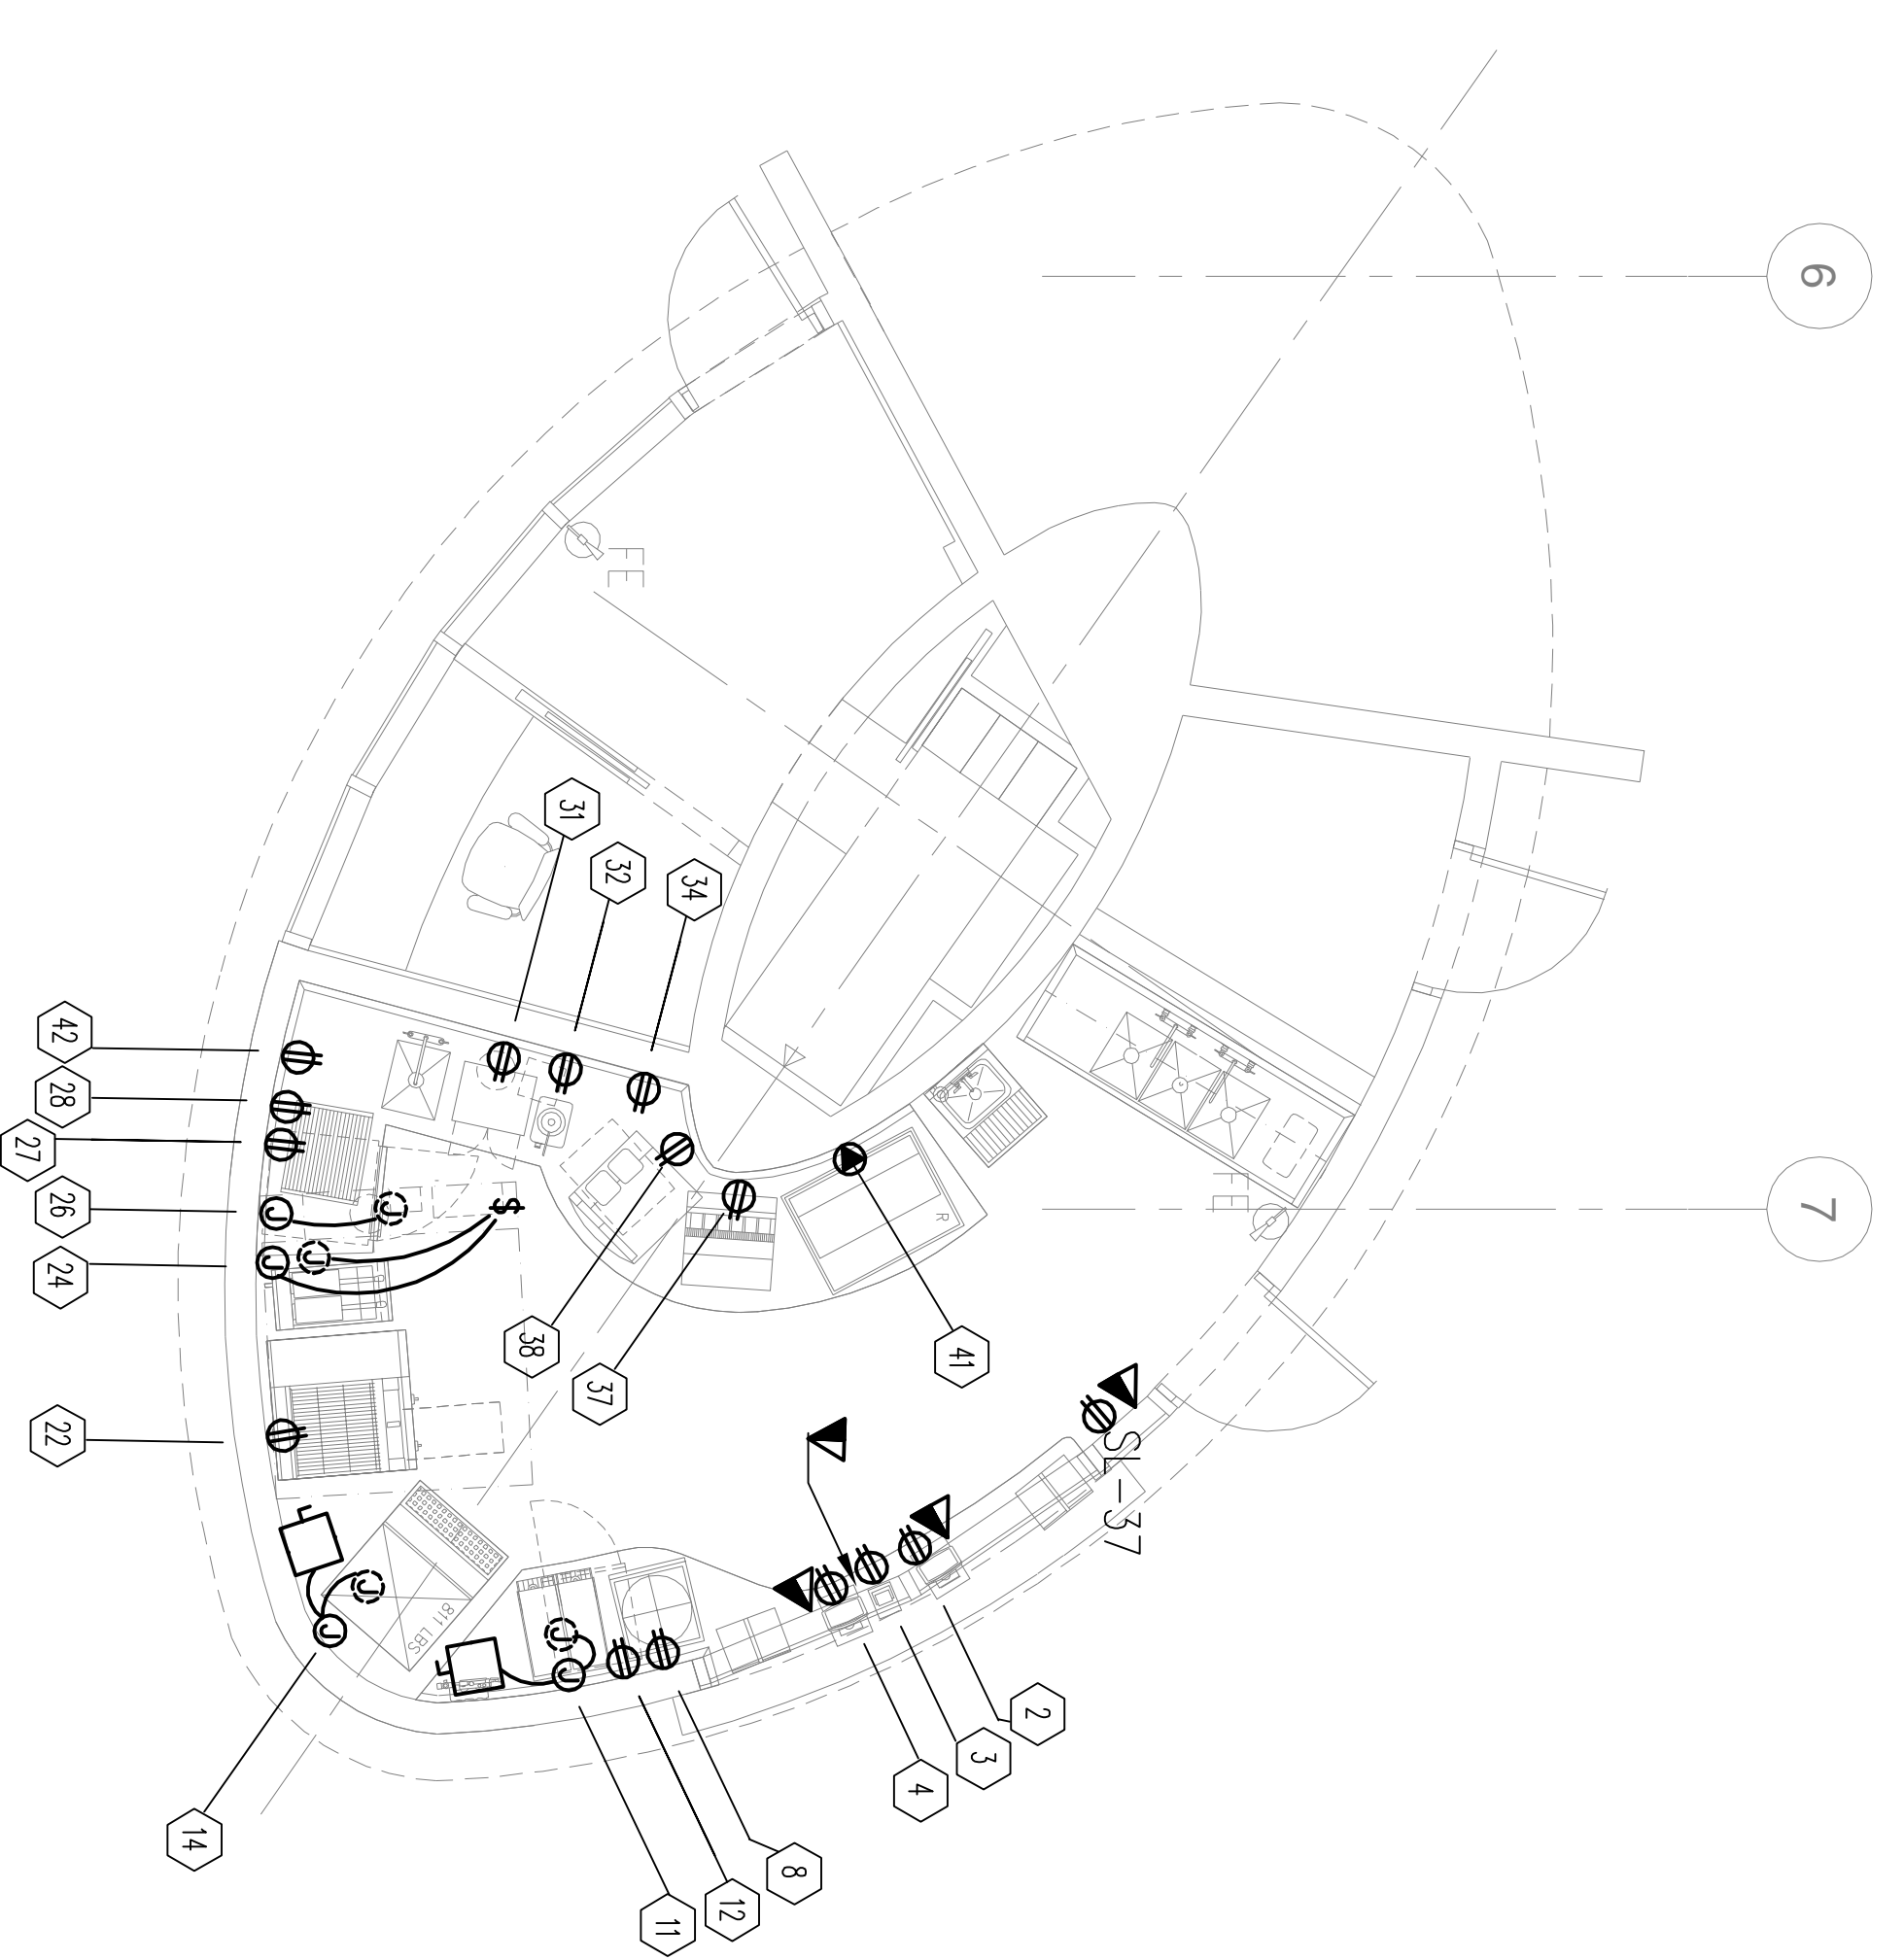

NO./QTY	DESCRIPTION	HGT	CONNECTION LOAD		PHASE	COMMENTS	E.E. BY/DATE	PANEL SL. NO.
			LOAD	WATTAGE				
1	FRONT COUNTER							1
2	P.O.S. STATION	24"	20.0A	120V	1PH	BRONZE SHIELD		2
3	P.O.S. STATION	24"	20.0A	120V	1PH	BRONZE SHIELD		3
4	P.O.S. STATION	24"	20.0A	120V	1PH	BRONZE SHIELD		4
5	SPARE NUMBER							5
6	CONDIMENT DISPLAY							6
7	BACK COUNTER							7
8	PRETZEL DISPLAY CASE	48"	11.8A	120V	1PH			8
9	SPARE NUMBER							9
10	SMOOTHIE MACHINE	48"	17.0A	208V	1PH			10
11	NOVELTY FREEZER	24"	8.3A	120V	1PH			11
12	WATER FILTRATION SYSTEM							12
13	ICE MACHINE	86"	13.8A	208V	1PH			13
14	ICE BIN							14
15	FLOOR TROUGH & GRATE							15
16	GARBAGE							16
17	SPARE NUMBER							17
18	SPARE NUMBER							18
19	SPARE NUMBER							19
20	SPARE NUMBER							20
21	PRETZEL BASE	24"	8.0A	120V	1PH			21
22	FRYER							22
23	EXHAUST HOOD							23
24	SPARE NUMBER							24
25	FINE SIFTER/STATION							25
26	UNDER-COUNTER REFRIGERATOR	24"	2.5A	120V	1PH			26
27	SPARE NUMBER							27
28	POP-CORN POPPER	48"	9.4A	120V	1PH			28
29	BUTTER DISPENSER	48"	4.2A	120V	1PH			29
30	CO2 BOTTLE							30
31	CARBONATOR	24"	21.1A	120V	1PH			31
32	SPARE NUMBER							32
33	UNDER-COUNTER SODA RACK							33
34	SODA DISPENSER	48"	15.0A	120V	1PH			34
35	SPRESSO/COFFEE MACHINE	48"	18.5A	120V	1PH	DEDICATED CIRCUIT		35
36	SPARE NUMBER							36
37	DROP-IN REFRIG. CASE	24"	12.6A	208V	1PH			37
38	BACK COUNTER W/SINK	48"	20.0A	120V	1PH	CONVENIENCE OUTLET		38
39	HAND/WOP SINK							39
40	3-COMPARTMENT SINK							40
41	SPARE NUMBER							41
42	WALL SHELF							42
43	TRASH RECEPTACLE							43
44	SPARE NUMBER							44
45	SPARE NUMBER							45
46	SPARE NUMBER							46
47	SPARE NUMBER							47
48	SPARE NUMBER							48

SNACK BAR ENLARGEMENT
POWER PLAN
 Scale: 1/4" = 1'-0"



ELECTRICAL SYMBOLS
 (* IF APPLICABLE)

SYMBOL	DESCRIPTION
	JUNCTION BOX W/ W/AL CONN. TO EQUIPMENT
	JUNCTION BOX (INSTALLED IN EQUIP. BY ELEC. OR MFG.)
	DUPLEX CONVENIENCE OUTLET
	SINGLE CONVENIENCE OUTLET
	FLOOR OUTLET, FLUSH OR RECESSED
	CLOCK OUTLET
	PULL BOX (INSTALLED IN EQUIP.)
	PLUG MOLDING
	POWER OUTLET, 1 PHASE
	POWER OUTLET, 3 PHASE (INSTALLED IN FABRICATED EQUIPMENT)
	POWER OUTLET, 3 PHASE (INSTALLED IN EQUIP. BY ELEC. OR MFG.)
	POWER OUTLET, 3 PHASE (INSTALLED IN EQUIP. BY ELEC. OR MFG.)
	POWER OUTLET, 3 PHASE (INSTALLED IN EQUIP. BY ELEC. OR MFG.)
	SWITCH
	VAPOR-PROOF LIGHT FIXTURE
	TELEPHONE
	DISCONNECT SWITCH

- KITCHEN ELECTRICAL NOTES**
 * IF APPLICABLE
- ELECTRICAL SYSTEM IS DESIGNED FOR 208/240 VOLTS, 3 PHASE, 4 WIRE, 60 HERTZ.
 - ALL OUTLETS AND CONNECTIONS SHOWN RELATE TO FOODSERVICE AND EQUIPMENT ONLY. SEE ENGINEERING PLANS FOR ADDITIONAL ELECTRICAL REQUIREMENTS.
 - THIS ELECTRICAL ROUGH-IN PLAN IS INTENDED TO SHOW OUTLET LOCATIONS, CONNECTION POSITIONS AND LOADS. ANY DIMENSIONS SHOWN ARE FROM COLUMN GRID LINES.
 - ALL ELECTRICAL WORK FOR FABRICATED FOODSERVICE EQUIPMENT SHALL BE COMPLETELY WIRED BY KITCHEN EQUIPMENT DIVISION TO A JUNCTION BOX OR PULL BOX MOUNTED ON THE EQUIPMENT IN AN ACCESSIBLE POSITION. FINAL CONNECTIONS TO EQUIPMENT JUNCTION-BOX OR PULL-BOX AND ALL ELECTRICAL WORK FROM PANEL BOARDS, TO BE BY THE ELECTRICAL CONTRACTOR.
 - FINAL CONNECTIONS TO ALL EQUIPMENT TO BE BY ELECTRICAL CONTRACTOR, INCLUDING MATERIALS.
 - ELECTRICAL CONTRACTOR TO FURNISH AND INSTALL THE FOLLOWING:
 - ALL JUNCTION-BOXES, ELECTRICAL OUTLETS, COVER PLATES/SWITCHES, ETC., NOT BUILT INTO FIXTURES OR EQUIPMENT. ALL OUTLETS, JUNCTION-BOXES, MUST BE VAPOR-PROOF.
 - ALL PLUGS AND CORDS AS NOTED ON SCHEDULE. ALL CORDS SHALL BE N.E.M.A.-RATED AND UL-APPROVED FOR MANUFACTURED AND/OR FABRICATED EQUIPMENT.
 - SHUNT-TYPE CIRCUIT BREAKERS OR DISCONNECTS FOR FIRE CONTROL SYSTEM SHUT-OFF OF FOODSERVICE EQUIPMENT BELOW HOODS/VENTILATORS AS REQUIRED BY N.F.P.A.-99, AND LOCAL CODES.
 - DISCONNECTS OR OTHER DEVICES AS REQUIRED BY CODES.
 - WHEN APPLICABLE, ELECTRICAL CONTRACTOR TO PROVIDE CONDUIT AND WIRING IN THE FOLLOWING:
 - REMOTE REFRIGERATION EQUIPMENT TO EVAPORATOR COILS.
 - CONTROL PANELS TO WATER-WASH VENTILATORS AND EXHAUST/SUPPLY FANS PER MANUFACTURER'S INSTRUCTIONS.
 - KITCHEN EXHAUST HOOD/VENTILATORS TO FIRE CONTROL SYSTEM AND SHUT-OFFS.
 - MOUNT & WIRE EXTRA WALK-IN COOLER / FREEZER LIGHTS PROVIDED BY K.E.C.

SEE FOOD SERVICE DRAWINGS